

# CITY OF DEER PARK

## Transfer Station Tenant Improvements Restroom Below Stairs Addition

### CITY MANAGER


James J. Stokes

### DIRECTOR OF PUBLIC WORKS

W. R. (Bill) Pedersen, P.E.

### CITY SECRETARY

Shannon Bennett

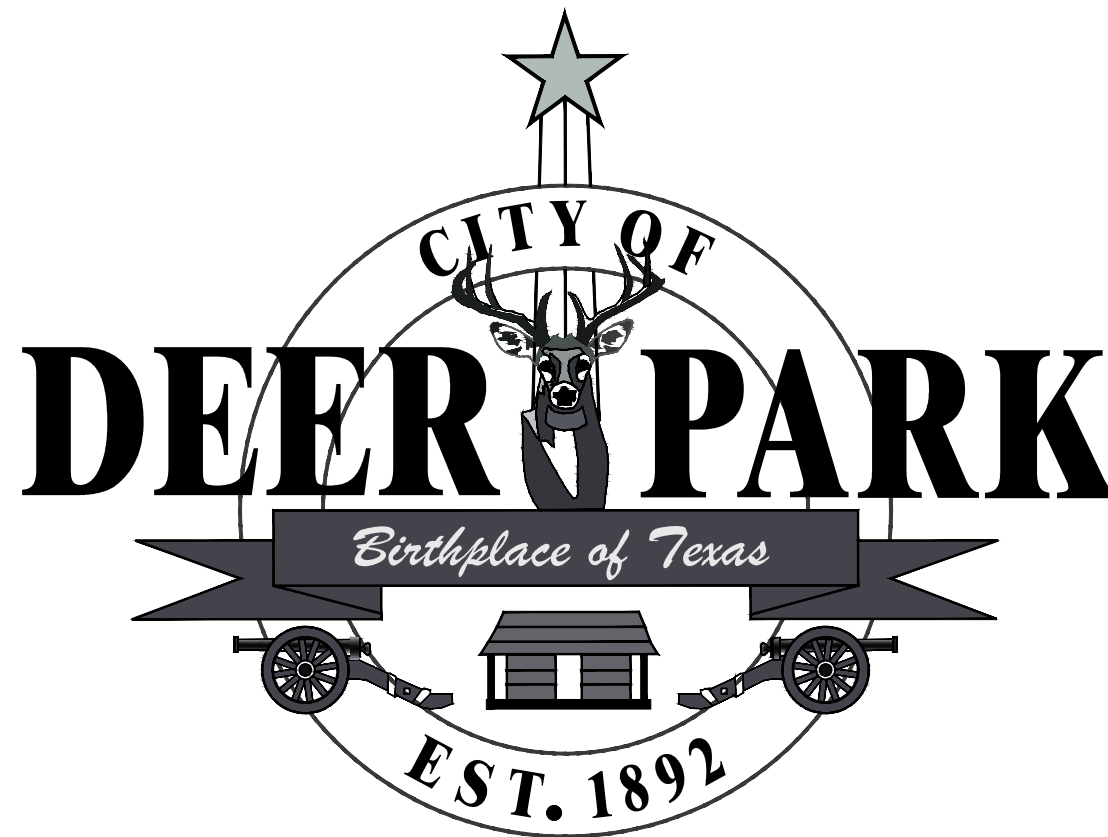

### MAYOR

Jerry Mouton


### COUNCIL MEMBERS

Position No. 1 – Sherry Garrison  
Position No. 2 – TJ Haight  
Position No. 3 – Tommy Ginn  
Position No. 4 – Bill Patterson  
Position No. 5 – Ron Martin  
Position No. 6 – Rae Sinor

710 E. SAN AUGUSTINE STREET  
DEER PARK, TEXAS 77536

MAY 2020

PROJECT NO. 3877-20

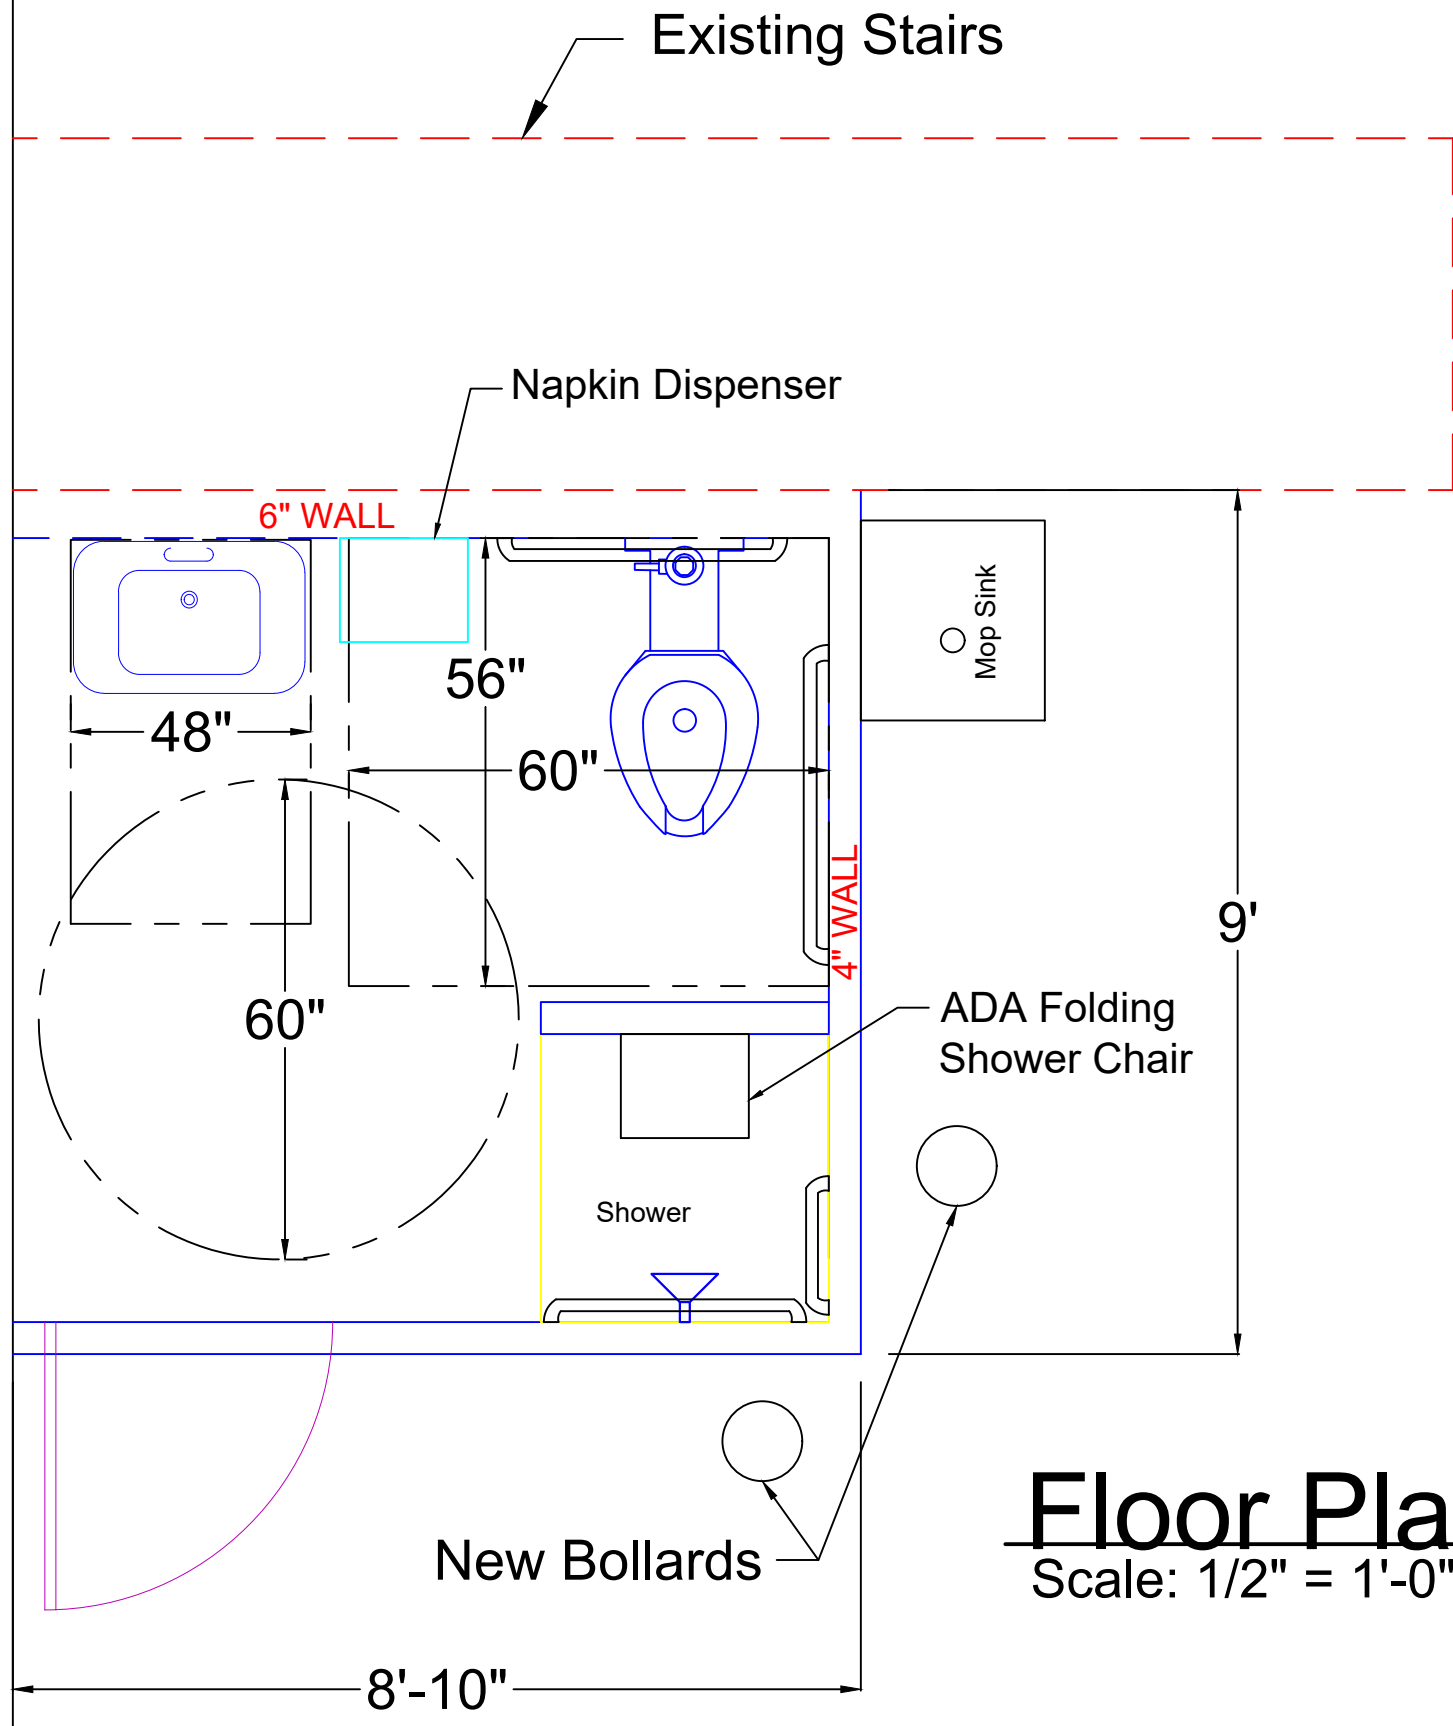



**Floor Plan**  
Scale: 1/2" = 1'-0"

NO.	DATE	DESCRIPTION	BY
1			
2			
3			
4			
5			
6			

DATE: MAY 2020  
 PROJECT NO. 3877-20  
 DRAWN BY: JAE  
 CHECKED BY:  
 SCALE:  
 CAD FILE NO.

CITY OF DEER PARK  
 TRANSFER STATION IMPROVEMENTS  
 RESTROOM UNDER STAIRS ADDITION

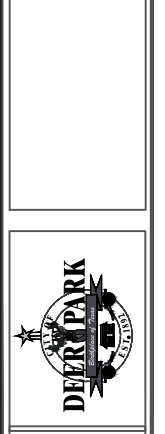

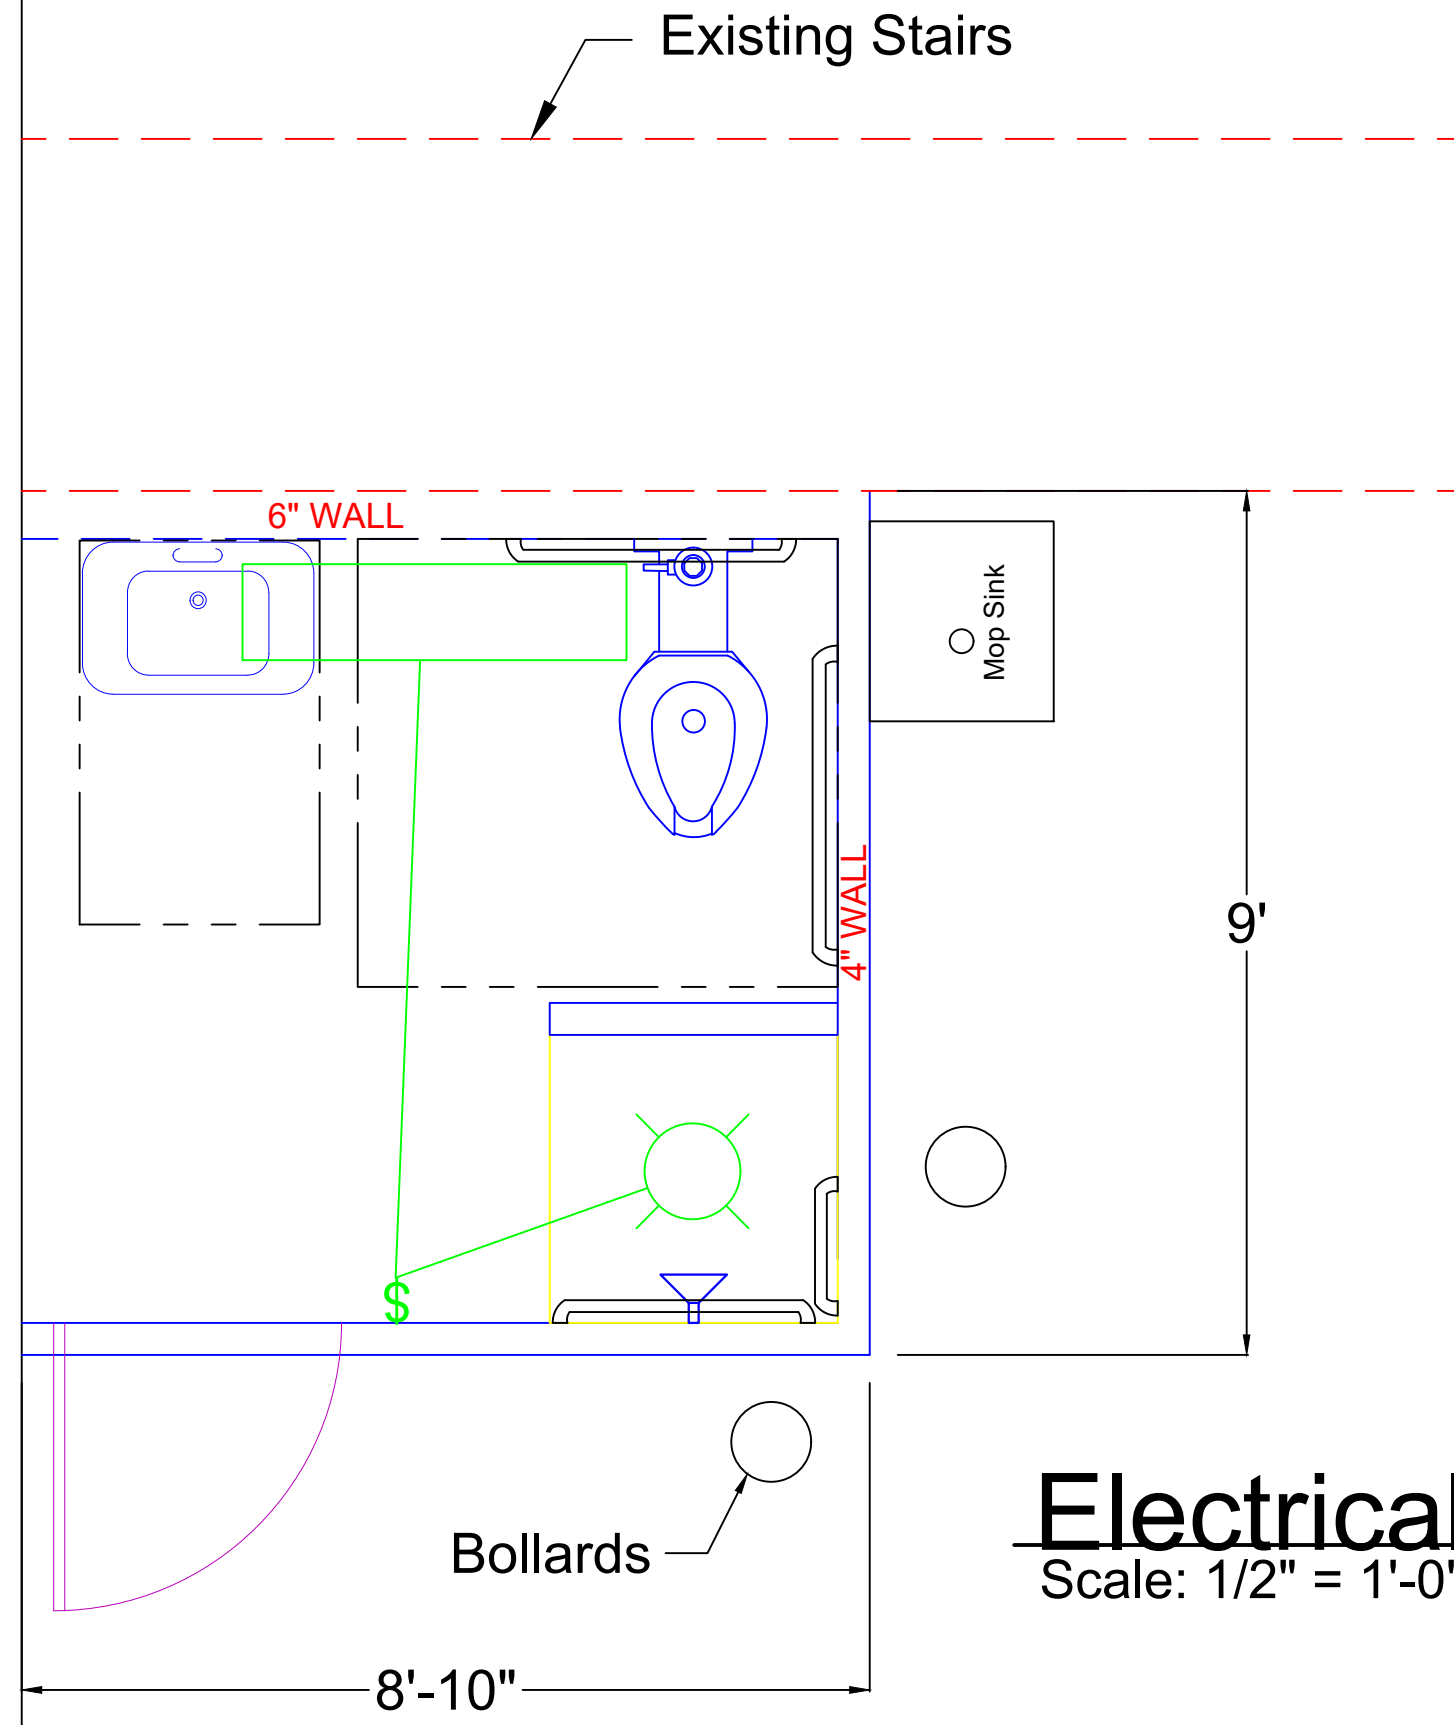

# Electrical Plan

Scale: 1/2" = 1'-0"

NO.	DESCRIPTION	DATE	BY
1			
2			
3			
4			
5			
6			

DATE: MAY 2020  
 PROJECT NO. 3877-20  
 DRAWN BY: JAE  
 CHECKED BY:  
 SCALE:  
 CAD FILE NO.

CITY OF DEER PARK  
 TRANSFER STATION IMPROVEMENTS  
 RESTROOM UNDER STAIRS ADDITION

