

SIGN TYPE A

REMOVE AND DISCARD EXISTING SIGN PAN TYPE FACES -
REPLACE WITH NEW VACUUM FORMED FACES
CLEAN AND REPAINT CABINET AND FCO ADDRESS
RETROFIT SIGN WITH NEW WHITE LED LIGHTS

OPTION #1



National Signs

2611 EL CAMINO
HOUSTON, TEXAS 77054
TEL: 713.863.0600 • FAX: 713.863.7585
www.NationalSigns.com

PROJECT: E.M. MAXWELL ADULT CTR

LOCATION: 1201 CENTER STREET

CITY/STATE: DEER PARK, TX ...

SALES REP: REBECCA BRUCE

DATE : 11.30.18

DRAWN BY: JORGE QUALITY REVIEW

DRAWING#: NS18 30315 FABRICATION READY



COPYRIGHT

THIS RENDERING IS THE PROPERTY OF NATIONAL SIGNS, LLC. ANY REPRODUCTION OR EXHIBITION OF THIS DRAWING IS STRICTLY PROHIBITED. ©2018 NATIONAL SIGNS, LLC. THIS RENDERING MAY NOT BE USED TO CONSTRUCT AND/OR BUILD WHAT IS DEPICTED HEREIN WITHOUT THE EXPRESS WRITTEN CONSENT OF NATIONAL SIGNS, LLC.

120 VOLT ELECTRICAL SERVICE

	SIGN	LED DISPLAY
ELECTRICAL LOAD		
20 AMP CIRCUIT(S)		

CLIENT TO PROVIDE ALL PRIMARY ELECTRICAL SERVICE TO THE SIGN UNLESS OTHERWISE SPECIFIED

REVISIONS

UL INSTALLATION REQUIREMENTS

THIS SIGN IS INTENDED TO BE INSTALLED IN ACCORDANCE WITH THE REQUIREMENTS OF ARTICLE 600 OF THE NATIONAL ELECTRICAL CODE AND/OR OTHER APPLICABLE LOCAL CODES. THIS INCLUDES PROPER GROUNDING AND BONDING OF THE SIGN.



EXISTING

SIGN DETAILS

SCALE: NOT TO SCALE

SIGN DETAILS

SCALE: 1/2" = 1'-0"

CLIENT APPROVAL

SIGNED:

DATE:

LANDLORD APPROVAL

SIGNED:

DATE:

SALES APPROVAL

SIGN TYPE A QUANTITY: 2 (1 PER SIDE)

REMOVE AND DISCARD EXISTING SIGN PAN TYPE FACES -
REPLACE WITH NEW VACUUM FORMED FACES
CLEAN AND REPAINT CABINET BASE AND FCO ADDRESS
RETROFIT SIGN WITH NEW WHITE LED LIGHTS

SPECIFICATIONS: FOR EXISTING CABINET & ADDRESS

- EXISTING - CABINET: CLEAN AND RE-PAINT P3
- EXISTING - CABINET BASE: CLEAN AND RE-PAINT P1
- EXISTING - FLAT CUT OUT ADDRESS: CLEAN AND RE-PAINT P2

SPECIFICATIONS: FOR NEW FACES

- .150 CLEAR POLYCARBONATE VACUUM FORMED PAN FACE
- 1 1/2" PAN DEPTH - SECOND SURFACE PAINTED P4
- 1/2" EMBOSSED COP - SECOND SURFACE - PAINTED P5 AND P6

RETROFIT SIGN WITH NEW WHITE LED LIGHTS AND POWER SUPPLIES

FINISH SCHEDULE

PAINT COLORS - FOR SIGN CABINET - SATIN FINISH

- P1: BLACK
- P2: WHITE
- P3: DEER PARK BURGUNDY

COLORS - FOR POLYCARBONATE FACES



- P4: TRANS. WHITE
- P5: TRANS. BURGUNDY 230-49
- P6: BLACK

APPROVED BY: _____



SURVEY
REQUIRED PRIOR
TO PRODUCTION

OPTION #1

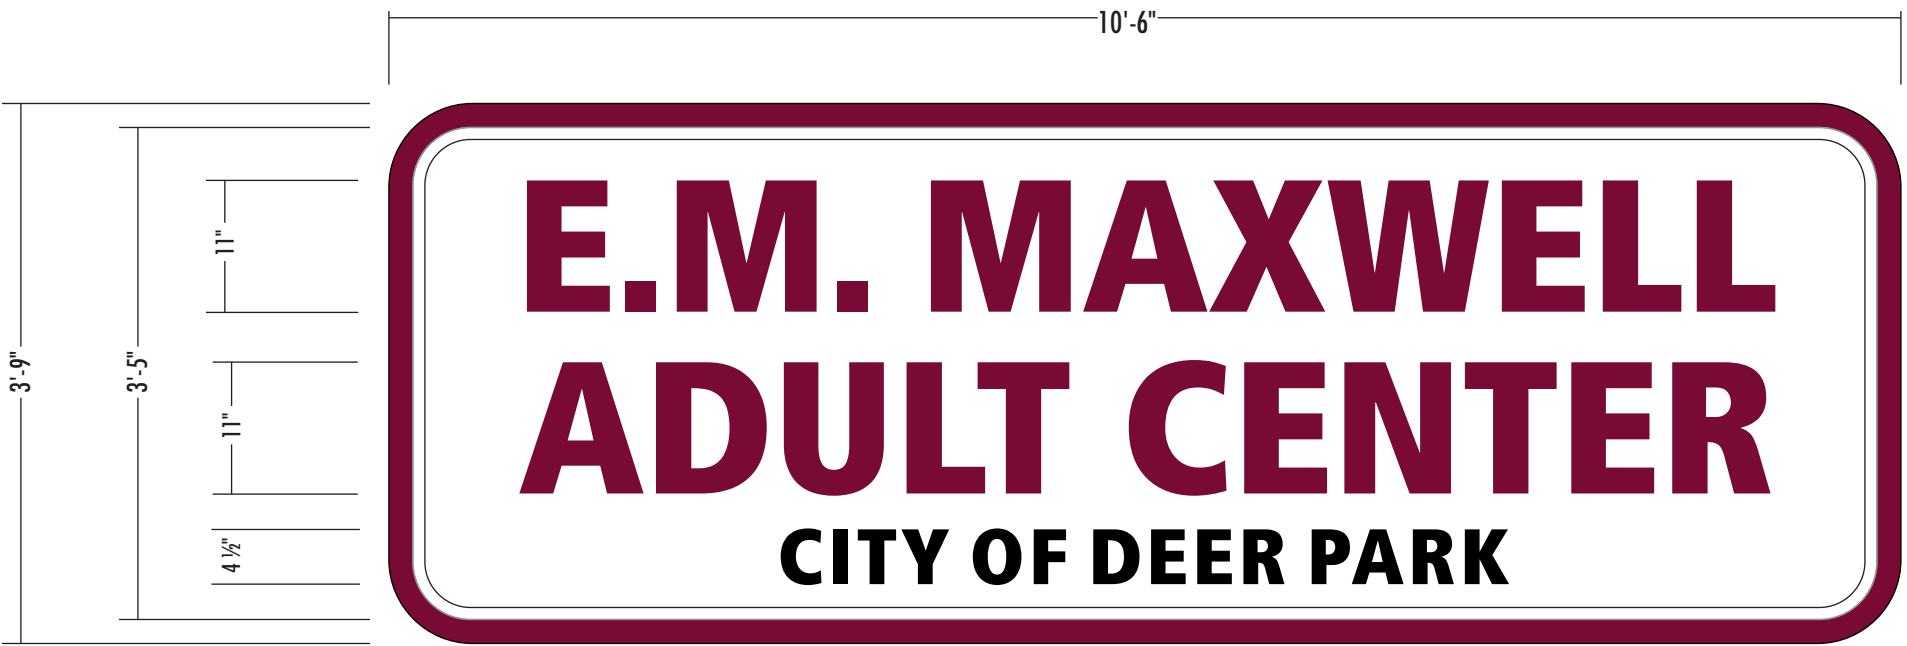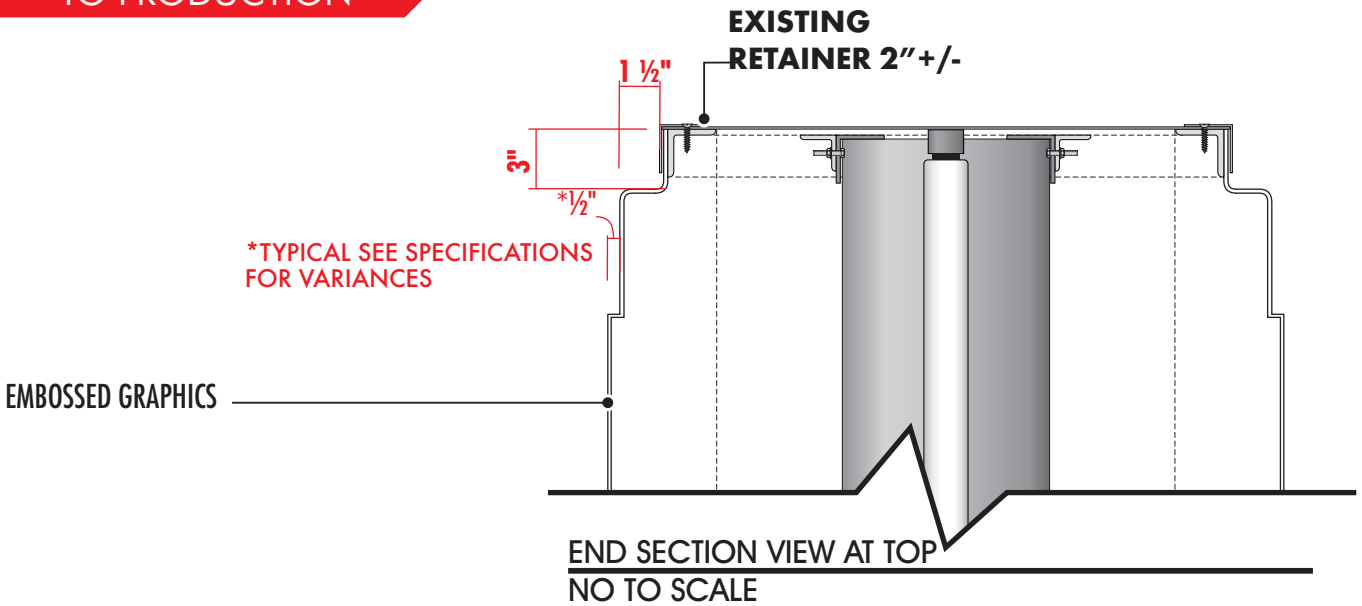

SIGN DETAILS

SCALE: 3/4" = 1'-0"

CLIENT APPROVAL SIGNED: _____

DATE: _____

LANDLORD APPROVAL SIGNED: _____

DATE: _____

Page 2 of 5

SALES APPROVAL _____



National Signs

2611 EL CAMINO
HOUSTON, TEXAS 77054
TEL: 713.863.0600 • FAX: 713.863.7585
www.NationalSigns.com

PROJECT: E.M. MAXWELL ADULT CTR

LOCATION: 1201 CENTER STREET

CITY/STATE: DEER PARK, TX ...

SALES REP: REBECCA BRUCE

DATE: 11.30.18

DRAWN BY: JORGE QUALITY REVIEW

DRAWING#: NS18 30315 FABRICATION READY



COPYRIGHT

THIS RENDERING IS THE PROPERTY OF NATIONAL SIGNS, LLC. ANY REPRODUCTION OR EXHIBITION OF THIS DRAWING IS STRICTLY PROHIBITED. ©2018 NATIONAL SIGNS, LLC. THIS RENDERING MAY NOT BE USED TO CONSTRUCT AND/OR BUILD WHAT IS DEPICTED HEREIN WITHOUT THE EXPRESS WRITTEN CONSENT OF NATIONAL SIGNS, LLC.

120 VOLT ELECTRICAL SERVICE

	SIGN	LED DISPLAY
ELECTRICAL LOAD		
20 AMP CIRCUIT(S)		

CLIENT TO PROVIDE ALL PRIMARY ELECTRICAL SERVICE TO THE SIGN UNLESS OTHERWISE SPECIFIED

REVISIONS

UL INSTALLATION REQUIREMENTS

THIS SIGN IS INTENDED TO BE INSTALLED IN ACCORDANCE WITH THE REQUIREMENTS OF ARTICLE 600 OF THE NATIONAL ELECTRICAL CODE AND/OR OTHER APPLICABLE LOCAL CODES. THIS INCLUDES PROPER GROUNDING AND BONDING OF THE SIGN.

SIGN TYPE A

REMOVE AND DISCARD EXISTING SIGN PAN TYPE FACES -
REPLACE WITH NEW VACUUM FORMED FACES
CLEAN AND REPAINT CABINET AND FCO ADDRESS
RETROFIT SIGN WITH NEW WHITE LED LIGHTS

OPTION #2



National Signs

2611 EL CAMINO
HOUSTON, TEXAS 77054
TEL: 713.863.0600 • FAX: 713.863.7585
www.NationalSigns.com

PROJECT: E.M. MAXWELL ADULT CTR

LOCATION: 1201 CENTER STREET

CITY/STATE: DEER PARK, TX ...

SALES REP: REBECCA BRUCE

DATE : 11.30.18

DRAWN BY: JORGE QUALITY REVIEW

DRAWING#: NS18 30315 FABRICATION READY



COPYRIGHT

THIS RENDERING IS THE PROPERTY OF NATIONAL SIGNS, LLC. ANY REPRODUCTION OR EXHIBITION OF THIS DRAWING IS STRICTLY PROHIBITED. ©2018 NATIONAL SIGNS, LLC. THIS RENDERING MAY NOT BE USED TO CONSTRUCT AND/OR BUILD WHAT IS DEPICTED HEREIN WITHOUT THE EXPRESS WRITTEN CONSENT OF NATIONAL SIGNS, LLC.

120 VOLT ELECTRICAL SERVICE

	SIGN	LED DISPLAY
ELECTRICAL LOAD		
20 AMP CIRCUIT(S)		

CLIENT TO PROVIDE ALL PRIMARY ELECTRICAL SERVICE TO THE SIGN UNLESS OTHERWISE SPECIFIED

REVISIONS

UL INSTALLATION REQUIREMENTS

THIS SIGN IS INTENDED TO BE INSTALLED IN ACCORDANCE WITH THE REQUIREMENTS OF ARTICLE 600 OF THE NATIONAL ELECTRICAL CODE AND/OR OTHER APPLICABLE LOCAL CODES. THIS INCLUDES PROPER GROUNDING AND BONDING OF THE SIGN.



SIGN DETAILS

SCALE: NOT TO SCALE

SIGN DETAILS

SCALE: 1/2" = 1'-0"

CLIENT APPROVAL

SIGNED:

DATE:

LANDLORD APPROVAL

SIGNED:

DATE:

SALES APPROVAL

SIGN TYPE A QUANTITY: 2 (1 PER SIDE)

REMOVE AND DISCARD EXISTING SIGN PAN TYPE FACES -
REPLACE WITH NEW VACUUM FORMED FACES
CLEAN AND REPAINT CABINET BASE AND FCO ADDRESS
RETROFIT SIGN WITH NEW WHITE LED LIGHTS

SPECIFICATIONS: FOR EXISTING CABINET & ADDRESS

- EXISTING - CABINET: CLEAN AND RE-PAINT P3
- EXISTING - CABINET BASE: CLEAN AND RE-PAINT P1
- EXISTING - FLAT CUT OUT ADDRESS: CLEAN AND RE-PAINT P2

SPECIFICATIONS: FOR NEW FACES

- .150 CLEAR POLYCARBONATE VACUUM FORMED PAN FACE
- 1 1/2" PAN DEPTH - SECOND SURFACE PAINTED P4
- 1/2" EMBOSSED COP - SECOND SURFACE - PAINTED P5 AND P6

RETROFIT SIGN WITH NEW WHITE LED LIGHTS AND POWER SUPPLIES

FINISH SCHEDULE

PAINT COLORS - FOR SIGN CABINET - SATIN FINISH

- P1: BLACK
- P2: WHITE
- P3: DEER PARK BURGUNDY

COLORS - FOR POLYCARBONATE FACES



- P4: TRANS. WHITE
- P5: TRANS. BURGUNDY 230-49
- P6: PTM - TRANS. GOLD NUGGET 230-131

APPROVED BY: _____



SURVEY
REQUIRED PRIOR
TO PRODUCTION

OPTION #2

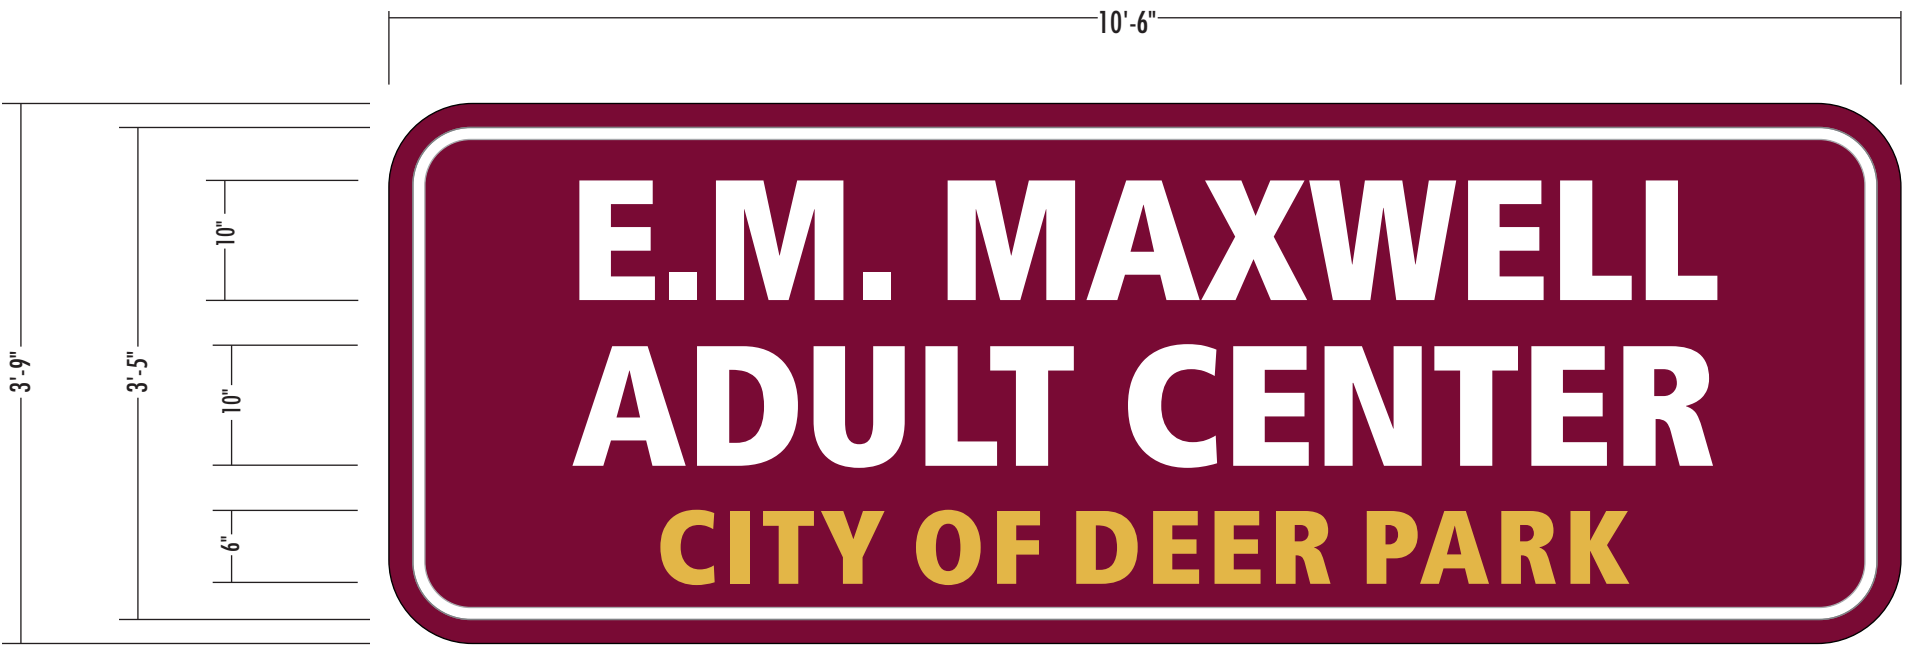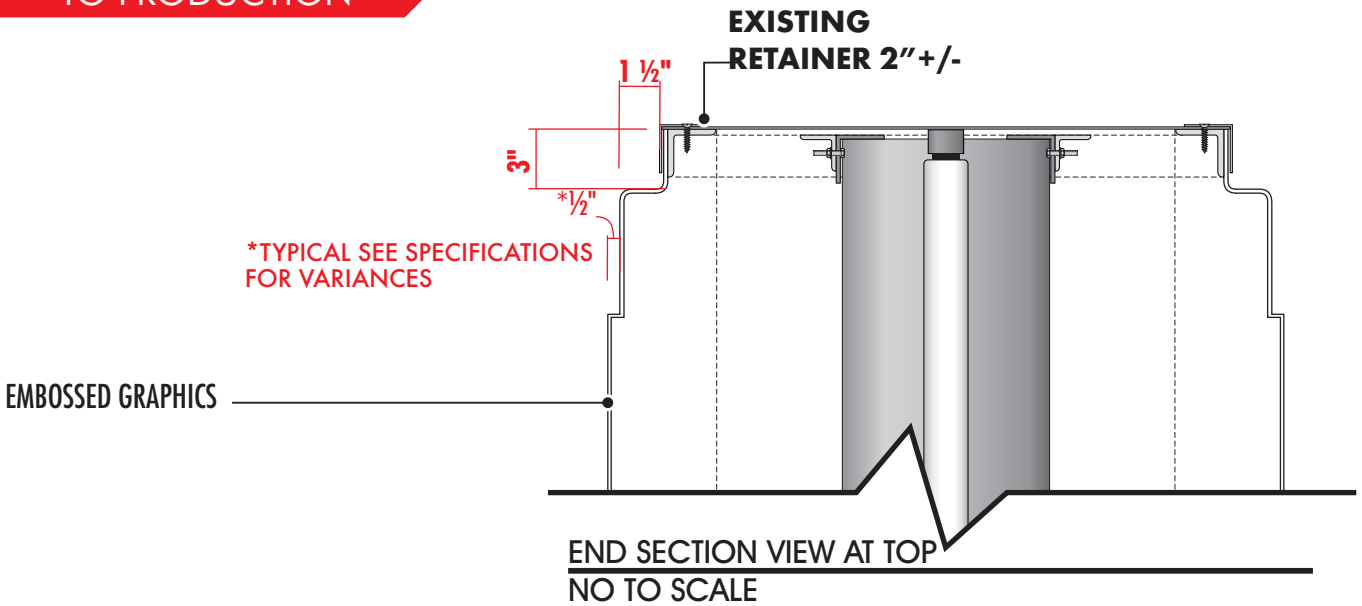

SIGN DETAILS

SCALE: 3/4" = 1'-0"

CLIENT APPROVAL

SIGNED: _____

DATE: _____

LANDLORD APPROVAL

SIGNED: _____

DATE: _____

Page 4 of 5

SALES APPROVAL



National Signs

2611 EL CAMINO
HOUSTON, TEXAS 77054
TEL: 713.863.0600 • FAX: 713.863.7585
www.NationalSigns.com

PROJECT: E.M. MAXWELL ADULT CTR

LOCATION: 1201 CENTER STREET

CITY/STATE: DEER PARK, TX ...

SALES REP: REBECCA BRUCE

DATE : 11.30.18

DRAWN BY: JORGE

QUALITY REVIEW

DRAWING#: NS18 30315 FABRICATION READY



COPYRIGHT

THIS RENDERING IS THE PROPERTY OF NATIONAL SIGNS, LLC. ANY REPRODUCTION OR EXHIBITION OF THIS DRAWING IS STRICTLY PROHIBITED. ©2018 NATIONAL SIGNS, LLC. THIS RENDERING MAY NOT BE USED TO CONSTRUCT AND/OR BUILD WHAT IS DEPICTED HEREIN WITHOUT THE EXPRESS WRITTEN CONSENT OF NATIONAL SIGNS, LLC.

120 VOLT ELECTRICAL SERVICE

	SIGN	LED DISPLAY
ELECTRICAL LOAD		
20 AMP CIRCUIT(S)		

CLIENT TO PROVIDE ALL PRIMARY ELECTRICAL SERVICE TO THE SIGN UNLESS OTHERWISE SPECIFIED

REVISIONS

UL INSTALLATION REQUIREMENTS

THIS SIGN IS INTENDED TO BE INSTALLED IN ACCORDANCE WITH THE REQUIREMENTS OF ARTICLE 600 OF THE NATIONAL ELECTRICAL CODE AND/OR OTHER APPLICABLE LOCAL CODES. THIS INCLUDES PROPER GROUNDING AND BONDING OF THE SIGN.

SIGN TYPE A

REMOVE AND DISPOSE OF EXISTING FLUORESCENT LAMPS, BALLASTS AND LAMP TRACKS. RETROFIT SIGN WITH NEW LED LIGHT ALUMINUM TUBE FRAMING WHITE LED LIGHTS AND POWER SUPPLIES



National Signs

2611 EL CAMINO
HOUSTON, TEXAS 77054
TEL: 713.863.0600 • FAX: 713.863.7585
www.NationalSigns.com

PROJECT: E.M. MAXWELL ADULT CTR

LOCATION: 1201 CENTER STREET

CITY/STATE: DEER PARK, TX ...

SALES REP: REBECCA BRUCE

DATE : 11.30.18

DRAWN BY: JORGE QUALITY REVIEW

DRAWING#: NS18 30315 FABRICATION READY



COPYRIGHT

THIS RENDERING IS THE PROPERTY OF NATIONAL SIGNS, LLC. ANY REPRODUCTION OR EXHIBITION OF THIS DRAWING IS STRICTLY PROHIBITED. ©2018 NATIONAL SIGNS, LLC. THIS RENDERING MAY NOT BE USED TO CONSTRUCT AND/OR BUILD WHAT IS DEPICTED HEREIN WITHOUT THE EXPRESS WRITTEN CONSENT OF NATIONAL SIGNS, LLC.

120 VOLT ELECTRICAL SERVICE


	SIGN	LED DISPLAY
ELECTRICAL LOAD		
20 AMP CIRCUIT(S)		

CLIENT TO PROVIDE ALL PRIMARY ELECTRICAL SERVICE TO THE SIGN UNLESS OTHERWISE SPECIFIED

REVISIONS

UL INSTALLATION REQUIREMENTS

THIS SIGN IS INTENDED TO BE INSTALLED IN ACCORDANCE WITH THE REQUIREMENTS OF ARTICLE 600 OF THE NATIONAL ELECTRICAL CODE AND/OR OTHER APPLICABLE LOCAL CODES. THIS INCLUDES PROPER GROUNDING AND BONDING OF THE SIGN.

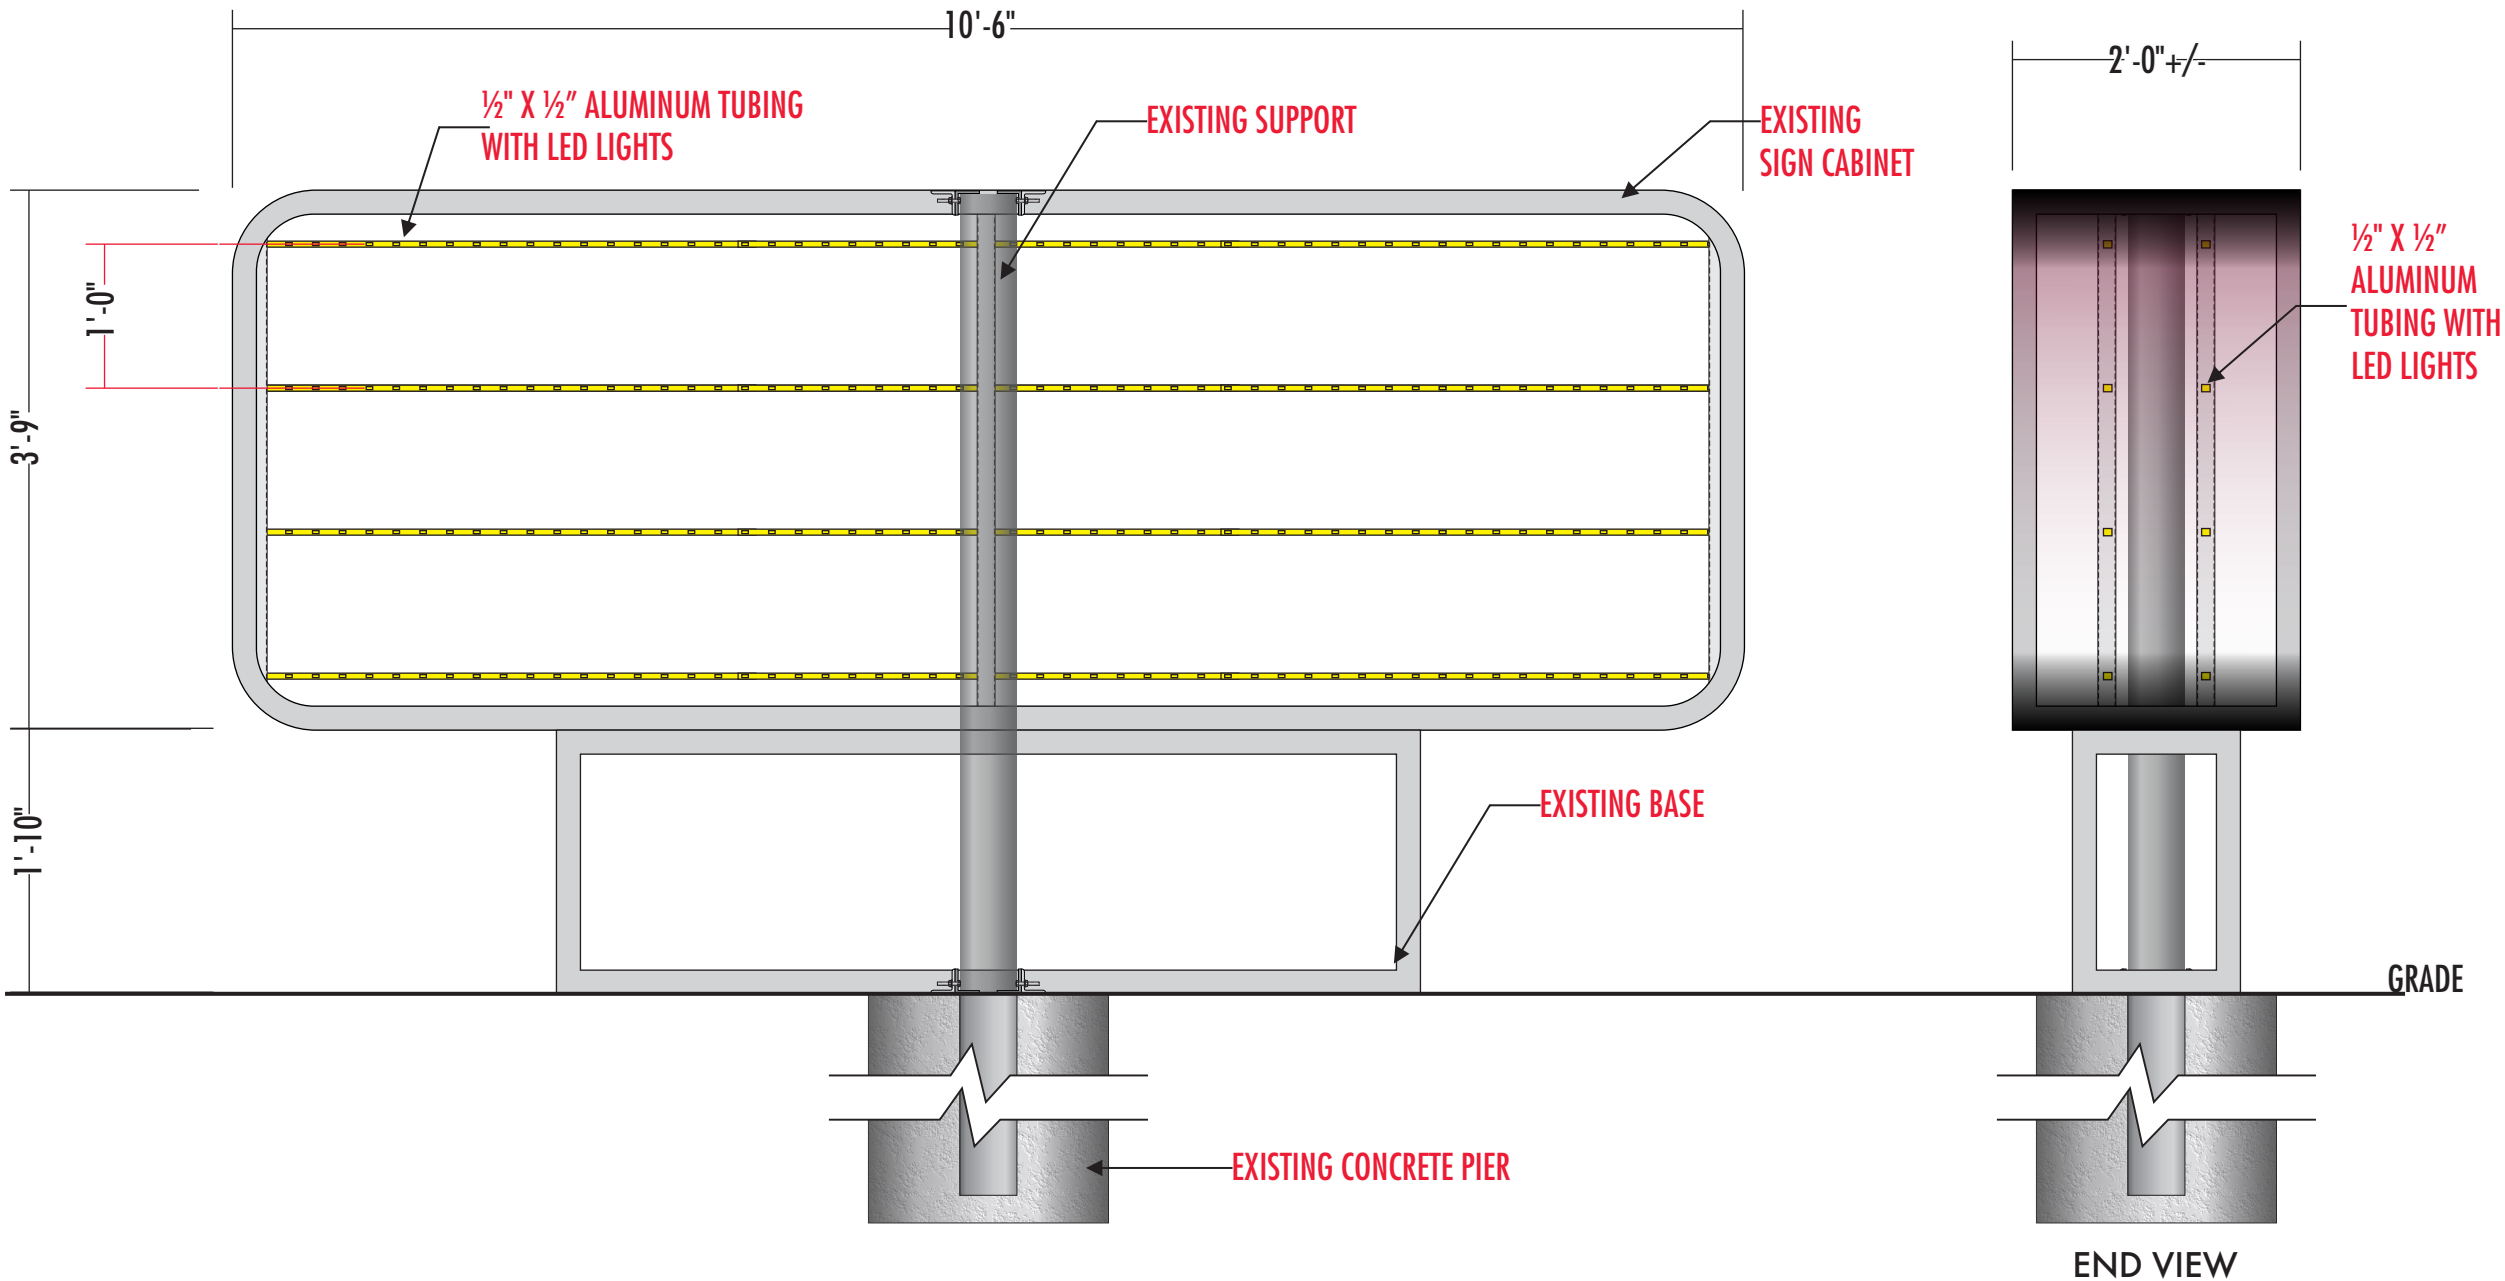

FRONT ELEVATION
SCALE: 3/4" = 1'-0"