

CITY OF DEER PARK

Transfer Station Tenant Improvements Shower Remodel

CITY MANAGER

James J. Stokes

DIRECTOR OF PUBLIC WORKS

W. R. (Bill) Pedersen, P.E.

CITY SECRETARY

Shannon Bennett



MAYOR

Jerry Mouton


COUNCIL MEMBERS

Position No. 1 – Sherry Garrison
Position No. 2 – TJ Haight
Position No. 3 – Tommy Ginn
Position No. 4 – Bill Patterson
Position No. 5 – Ron Martin
Position No. 6 – Rae Sinor

710 E. SAN AUGUSTINE STREET
DEER PARK, TEXAS 77536


MAY 2020

PROJECT NO. 3877-20

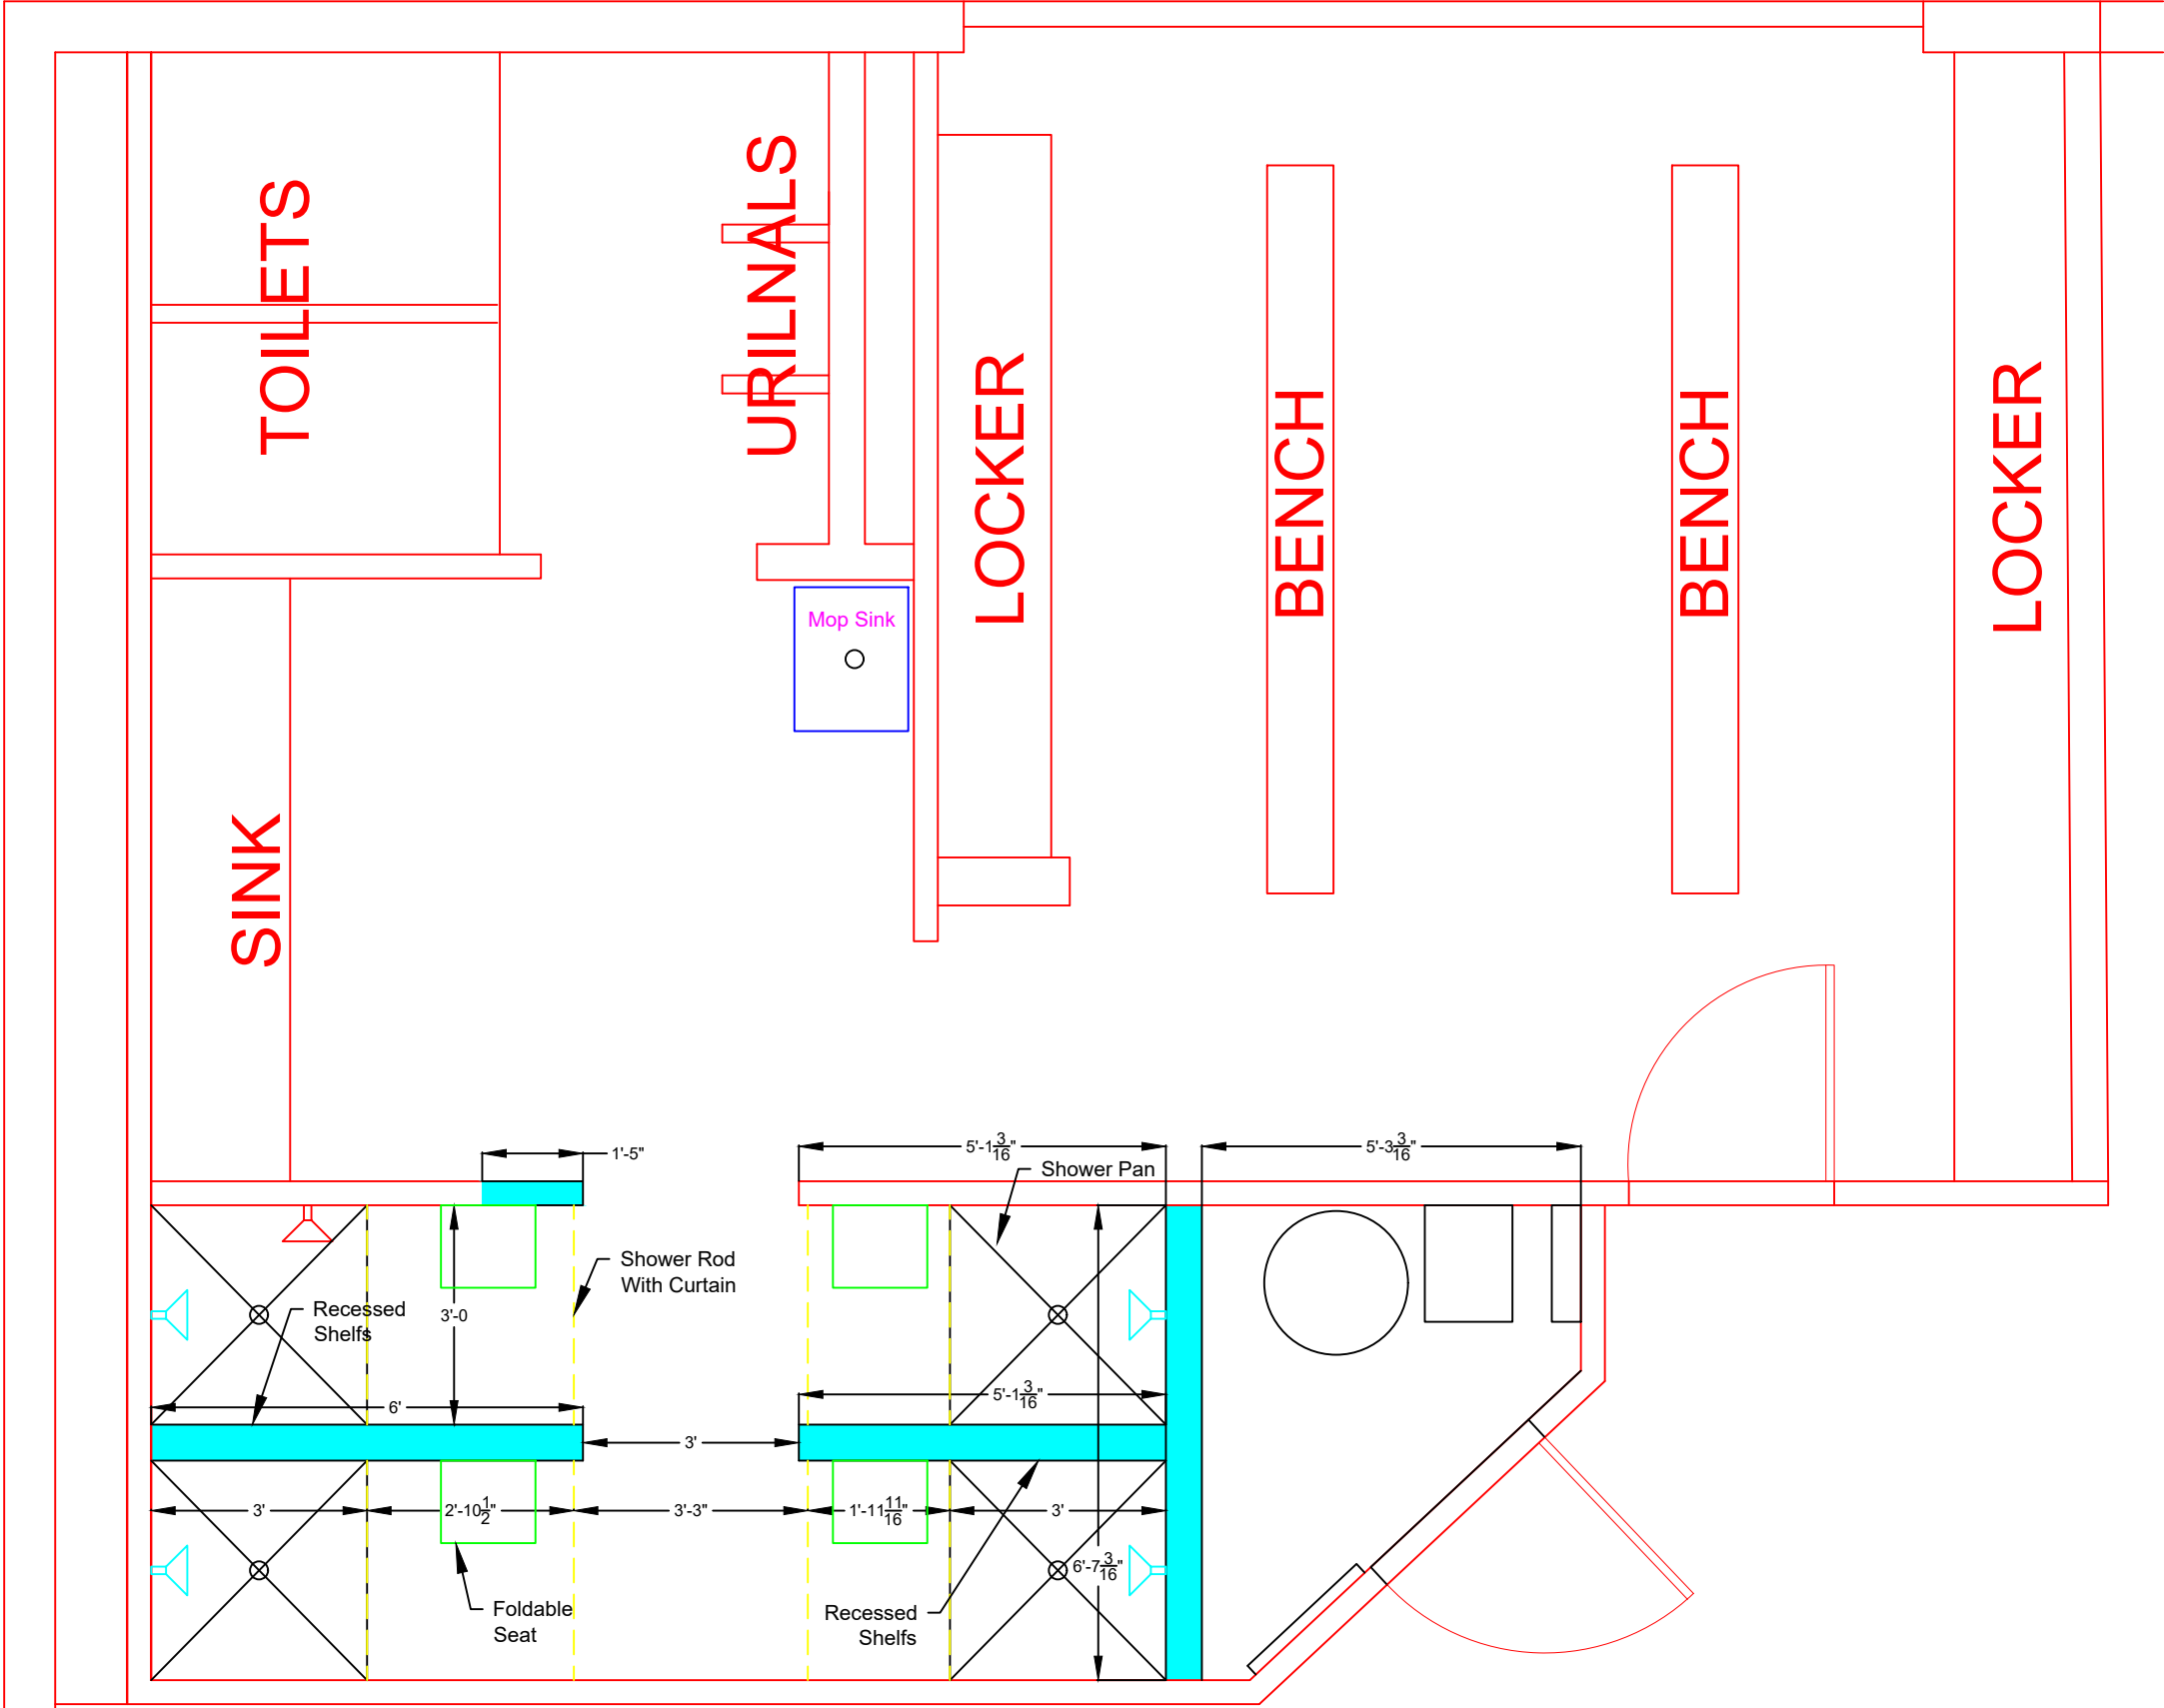

CITY OF DEER PARK
TRANSFER STATION SHOWER LOCKER ROOM REMODEL
FLOOR PLAN DESIGN 2

DATE: APRIL 2020					1	
PROJECT NO. 3879-20					2	
DRAWN BY: JAE					3	
CHECKED BY:					4	
SCALE: N/A					5	
CAD FILE NO.					6	
</						

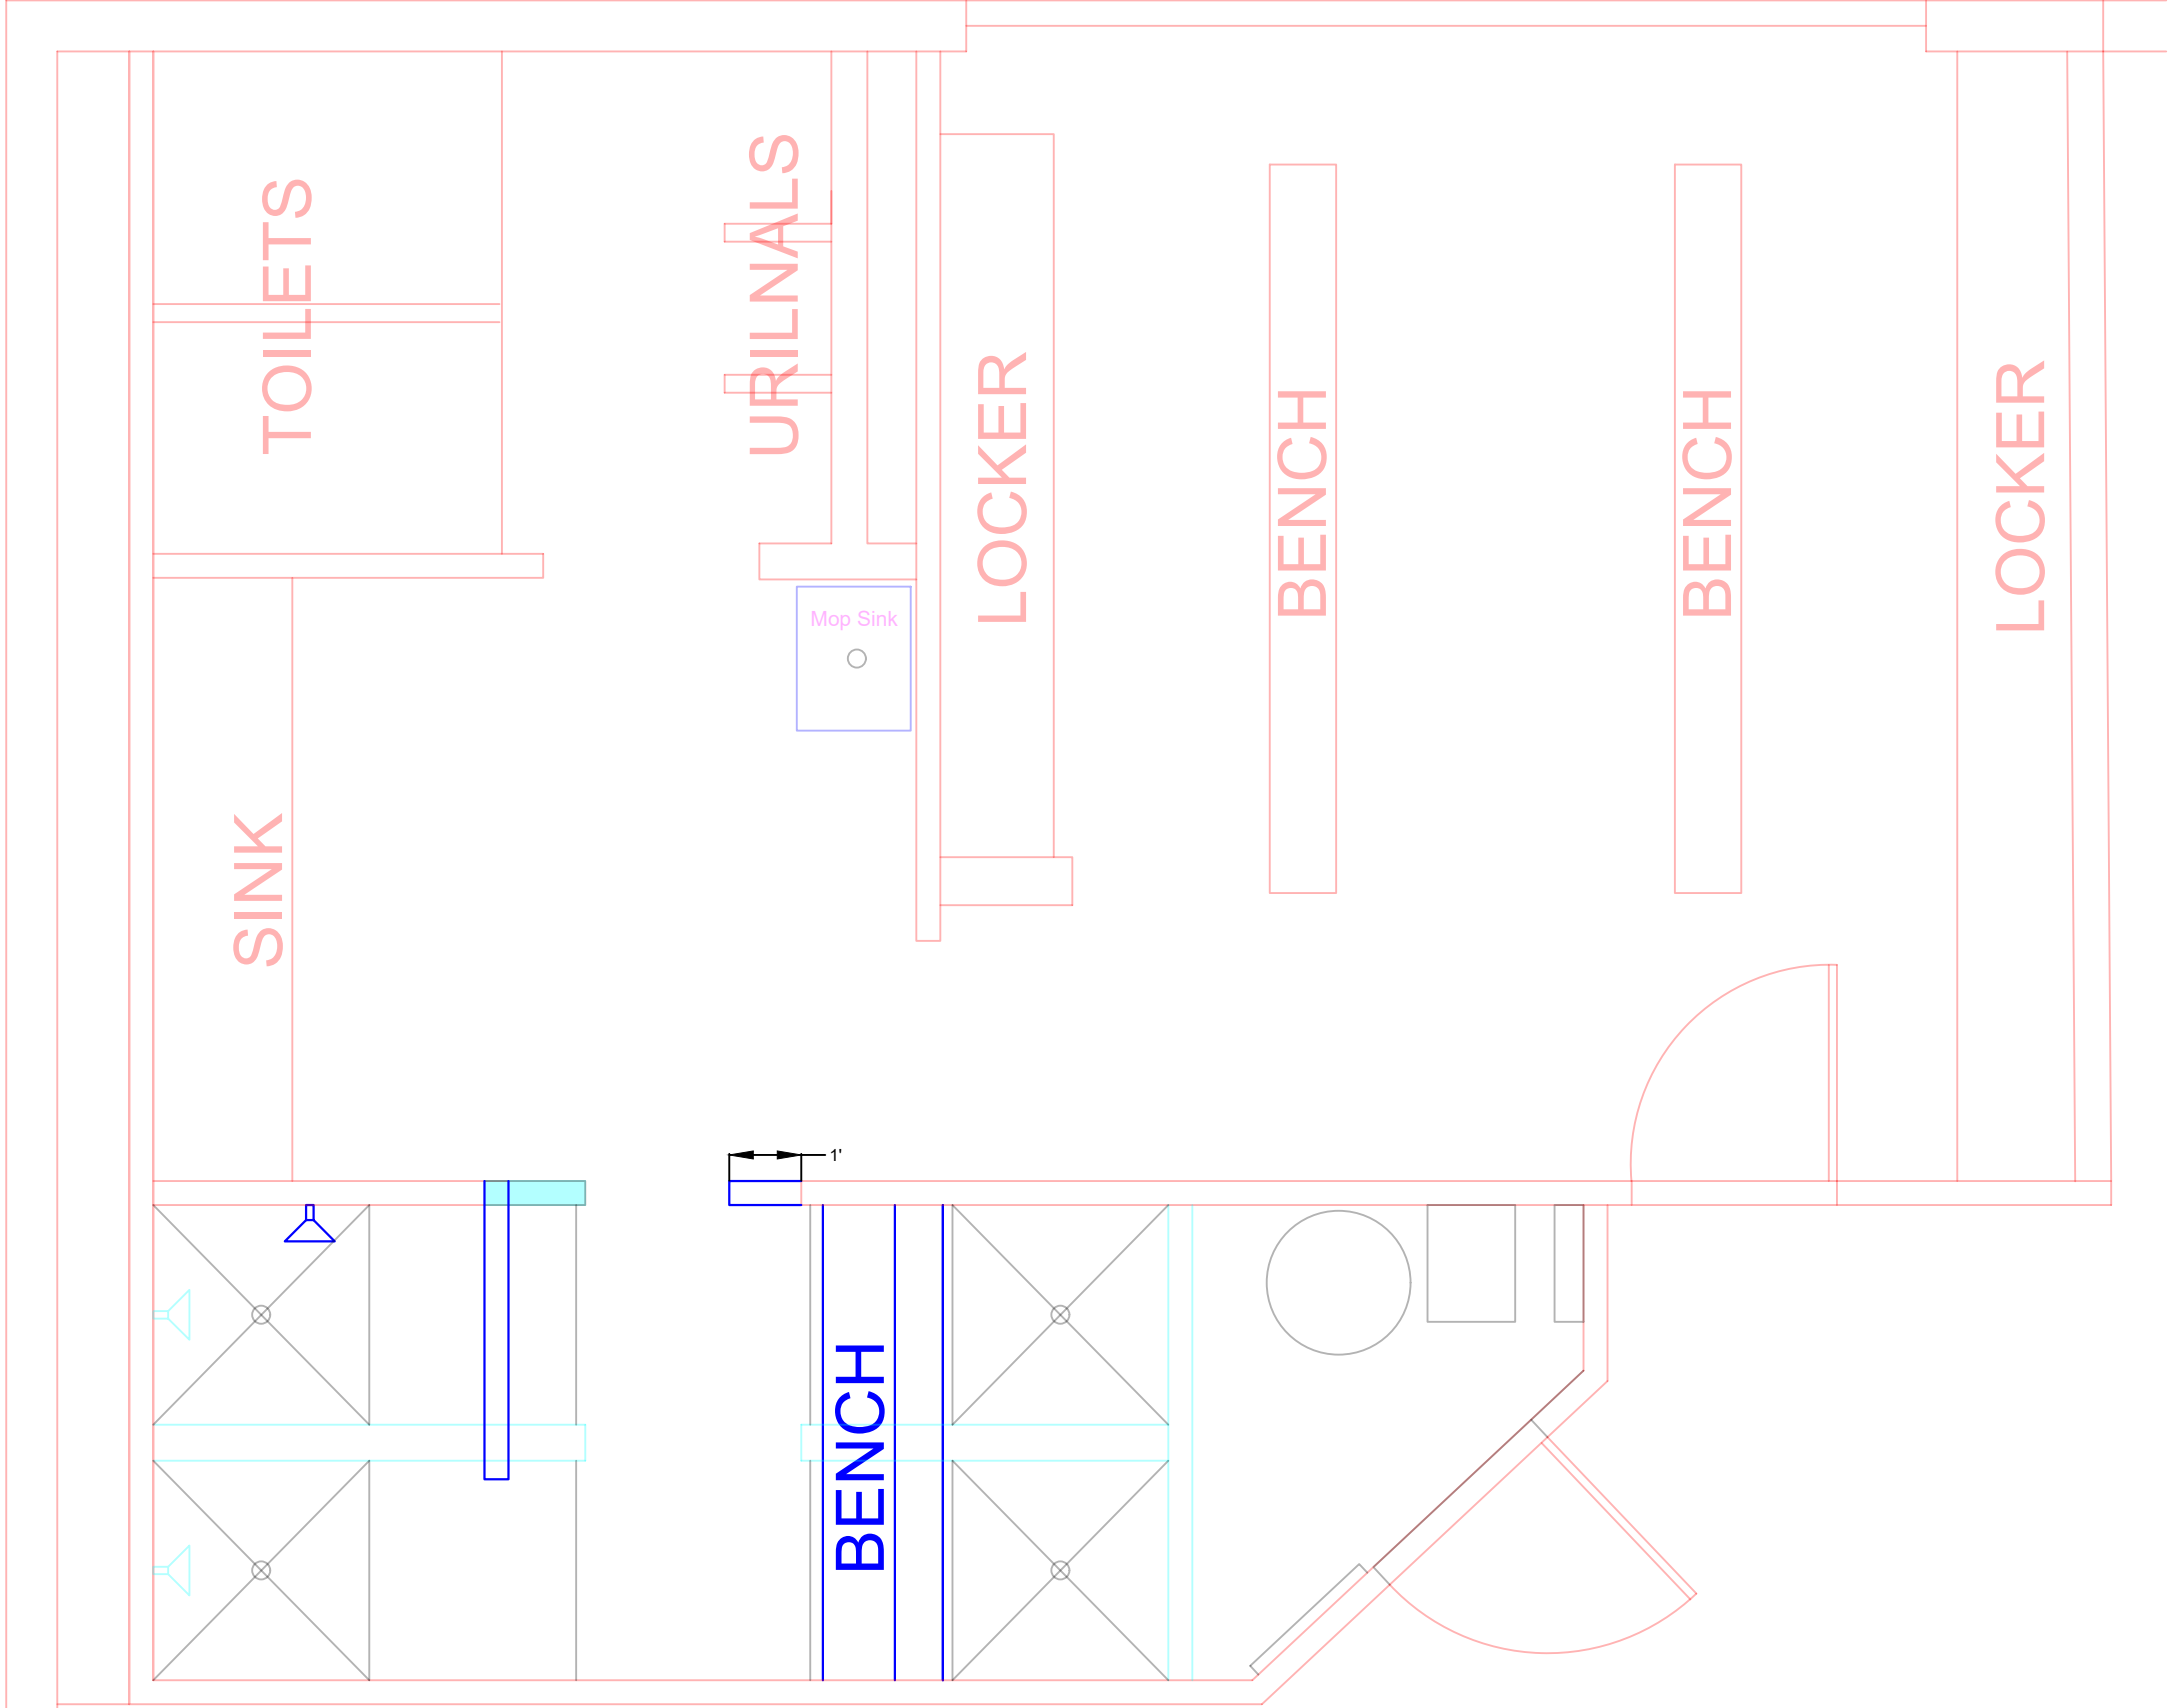

DEMOLITION PLAN




CITY OF DEER PARK
TRANSFER STATION SHOWER LOCKER ROOM REMODEL
DEMOLITION PLAN

SHEET
3 OF 5

DATE: APRIL 2020
PROJECT NO. 3879-20
DRAWN BY: JAE
CHECKED BY:
SCALE: N/A
CAD FILE NO.

REVISIONS

NO.	DESCRIPTION	DATE	BY
1			
2			
3			
4			
5			
6			

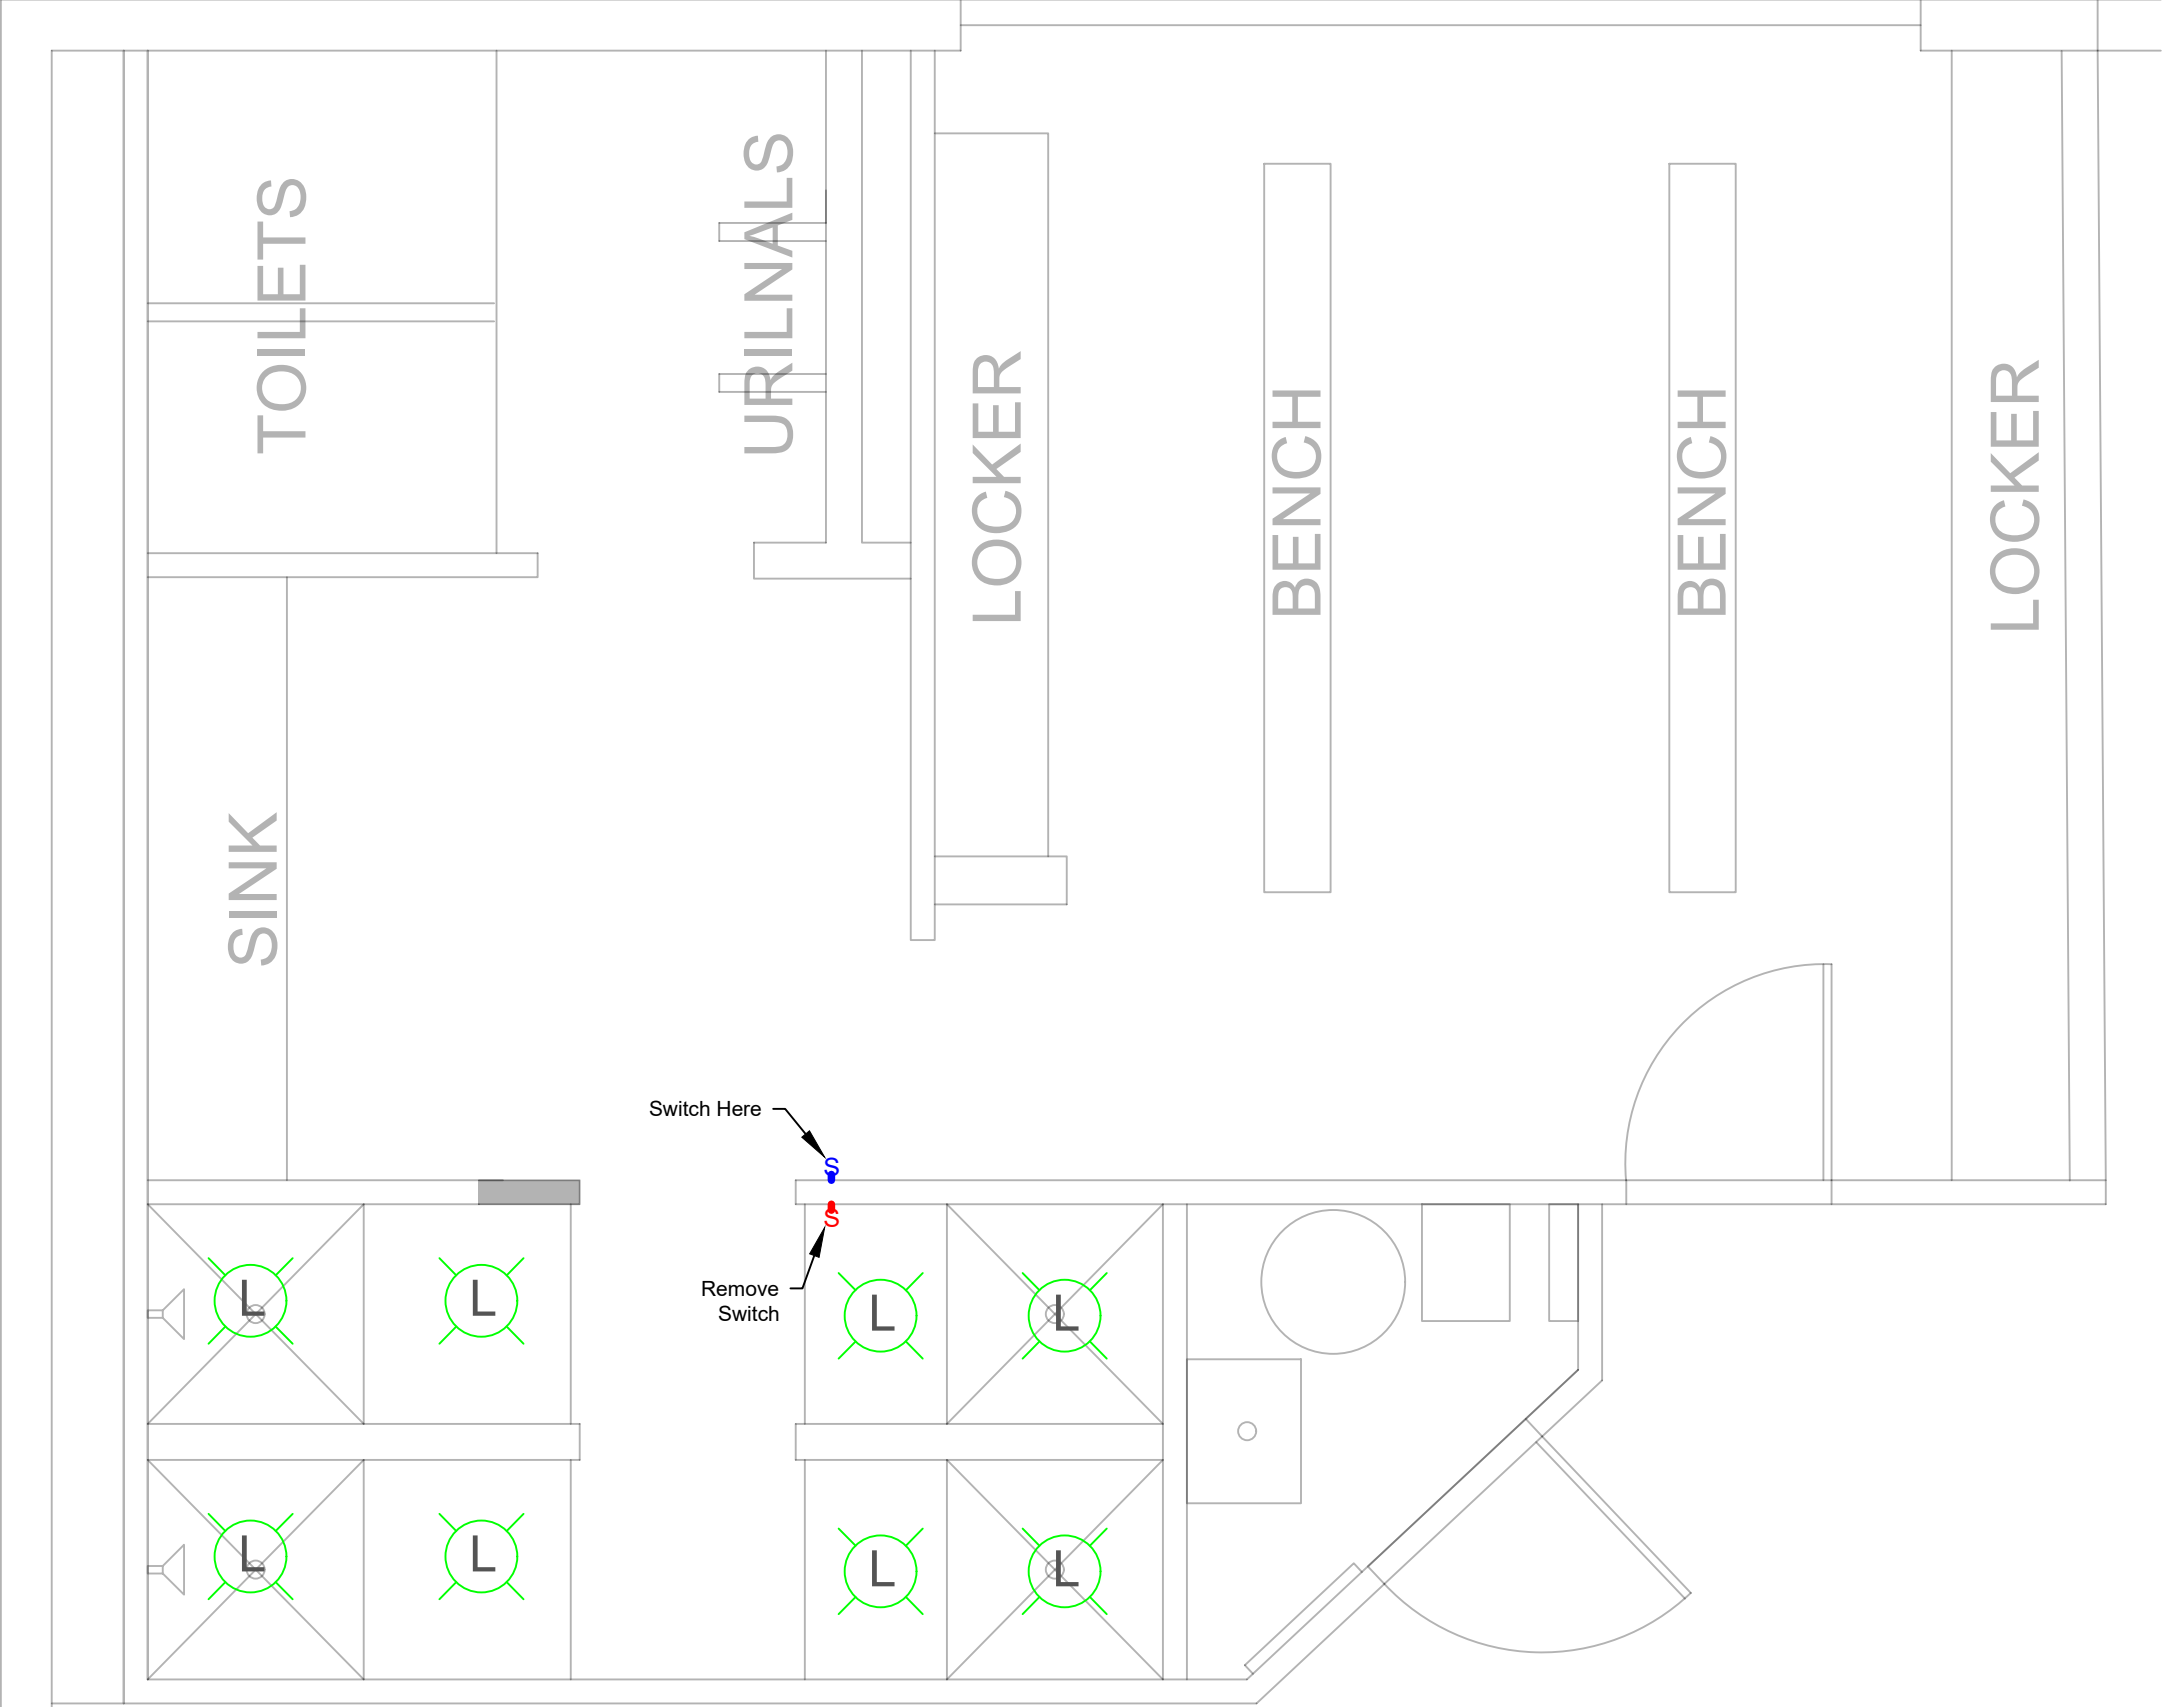

LEGEND

Light Switch
Ceiling Light



ELECTRICAL PLAN




CITY OF DEER PARK
TRANSFER STATION SHOWER LOCKER ROOM REMODEL
ELECTRICAL PLAN

DATE: APRIL 2020
PROJECT NO. 3879-20
DRAWN BY: JAE
CHECKED BY:
SCALE: N/A
CAD FILE NO.

REVISIONS


NO.	DATE	DESCRIPTION	BY
1			
2			
3			
4			
5			
6			

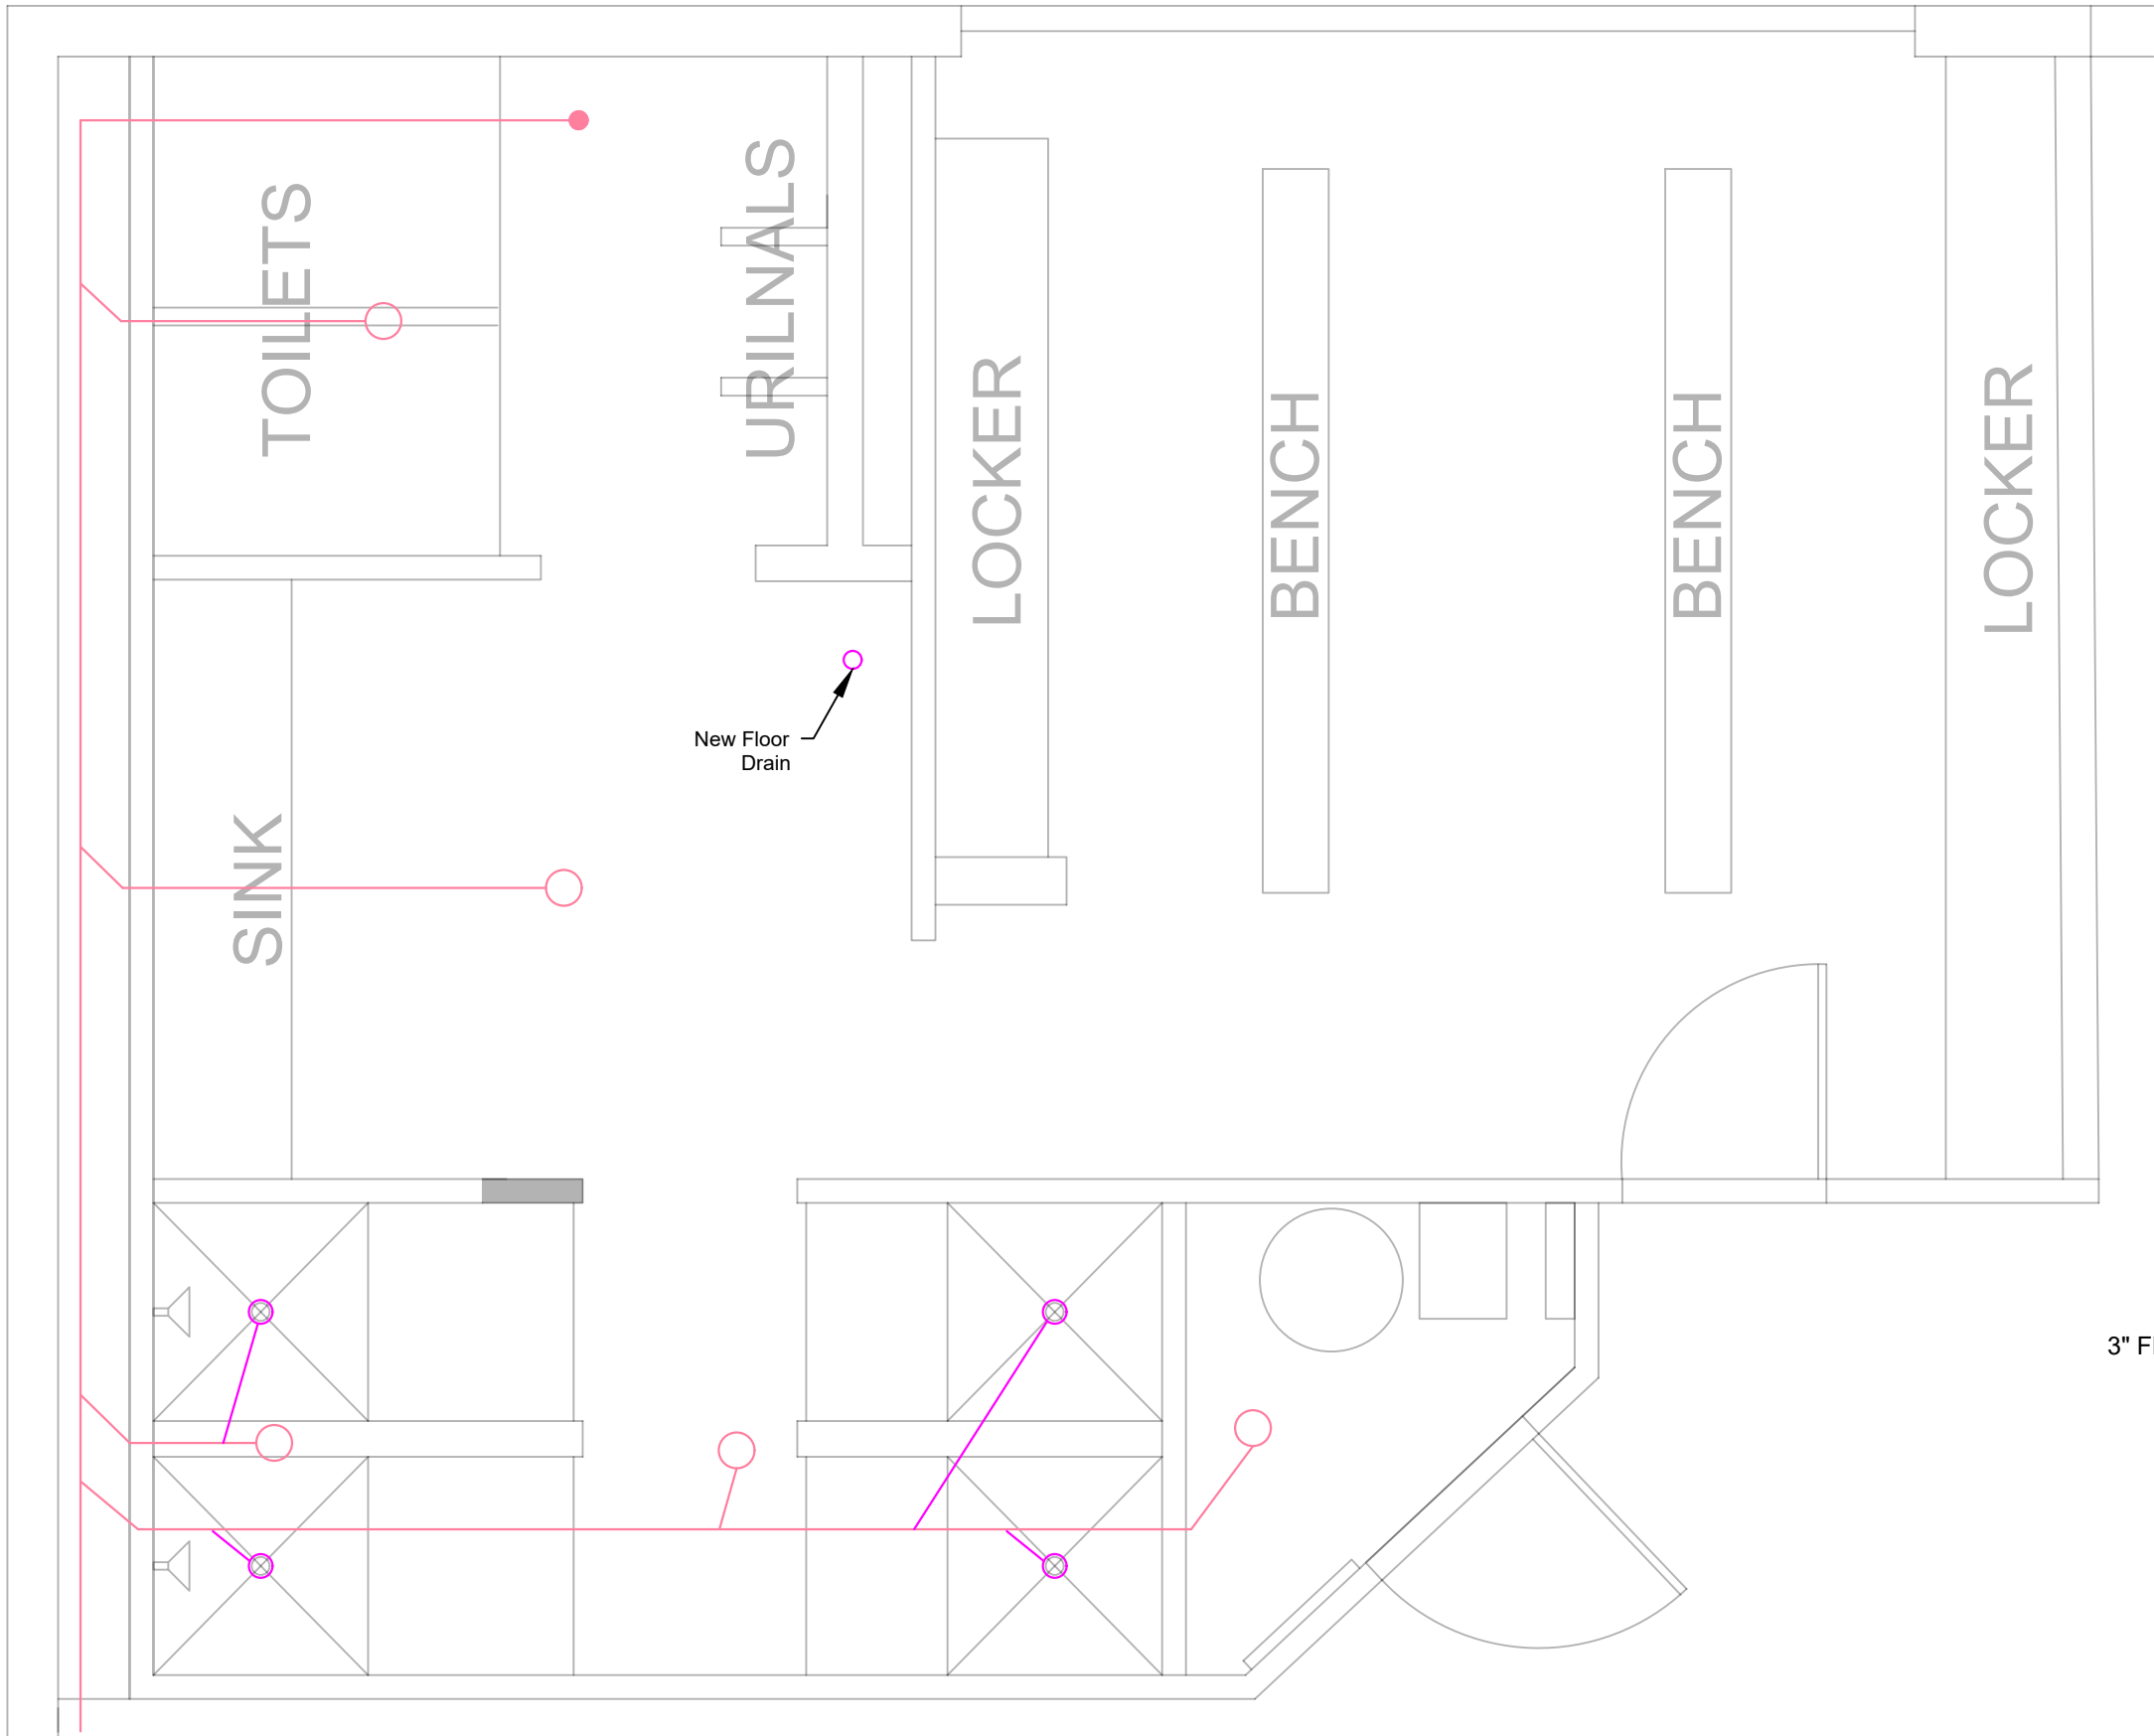

PLUMBING FLOOR PLAN

EXISTING PLUMBING
PROPOSED PLUMBING
FD
SVTR

LEGEND
FLOOR DRAIN
STANDARD VENT
THRU ROOF

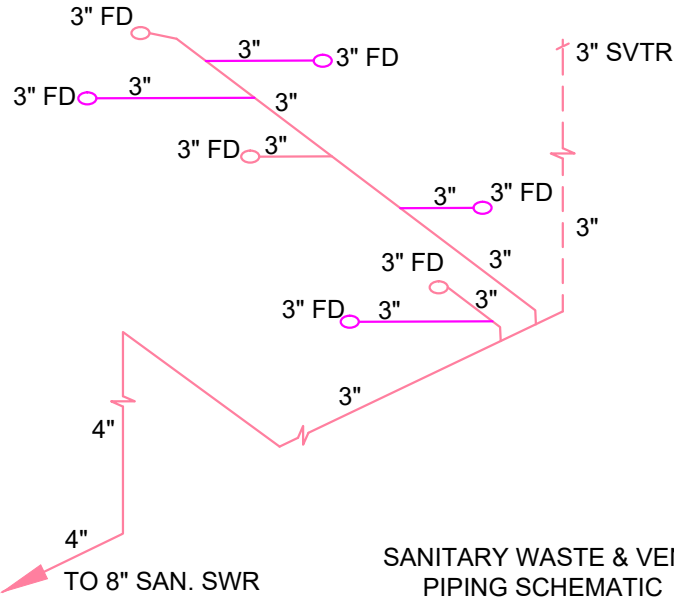

**SANITARY WASTE & VENT
PIPING SCHEMATIC**

DATE: APRIL 2020
PROJECT NO. 3879-20
DRAWN BY: JAE
CHECKED BY:
SCALE: N/A
CAD FILE NO.

CITY OF DEER PARK
TRANSFER STATION SHOWER LOCKER ROOM REMODEL
PLUMBING PLAN



SHEET

5 OF 5

REVISIONS

NO.	DATE	DESCRIPTION	BY
1			
2			
3			
4			
5			
6			